



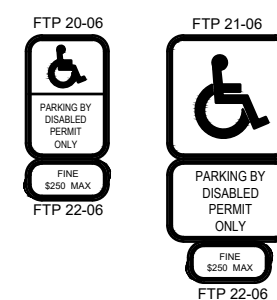
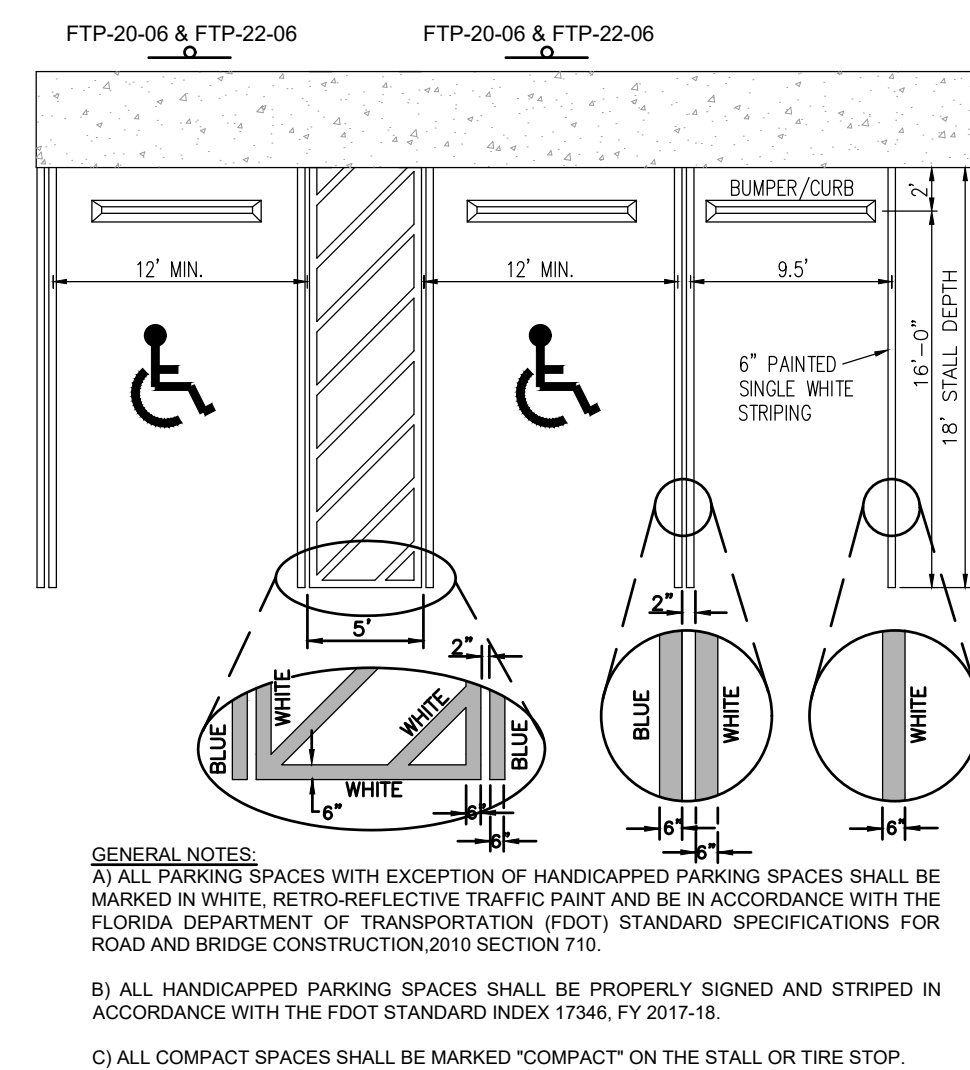
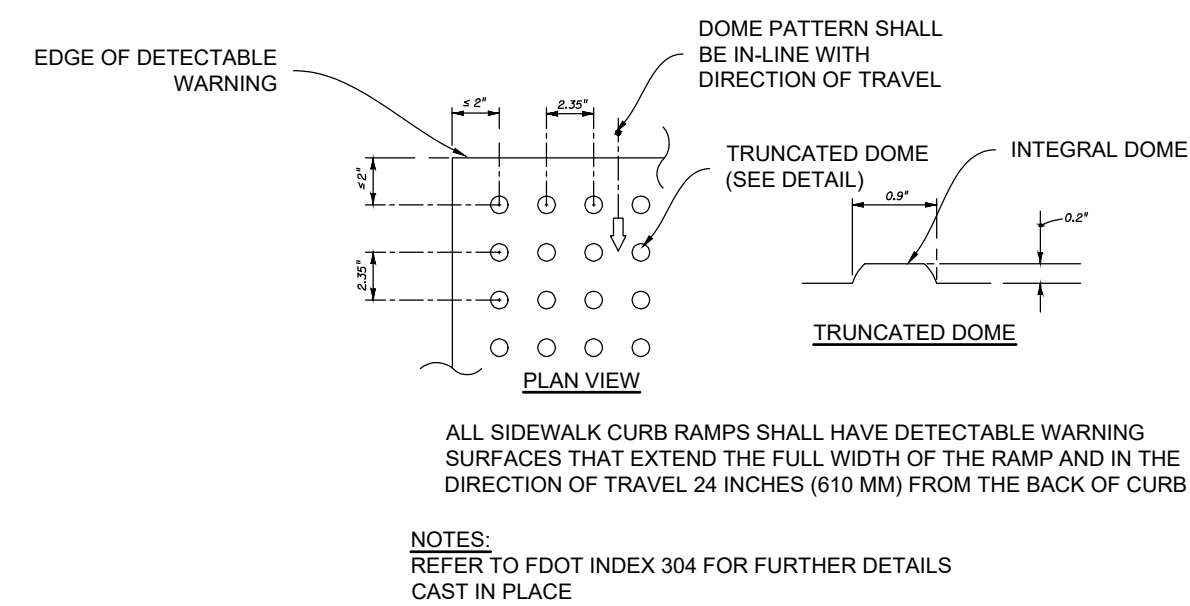
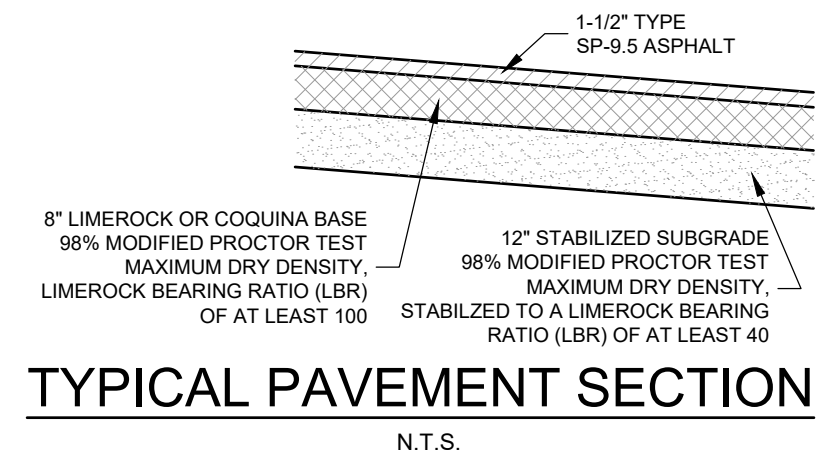
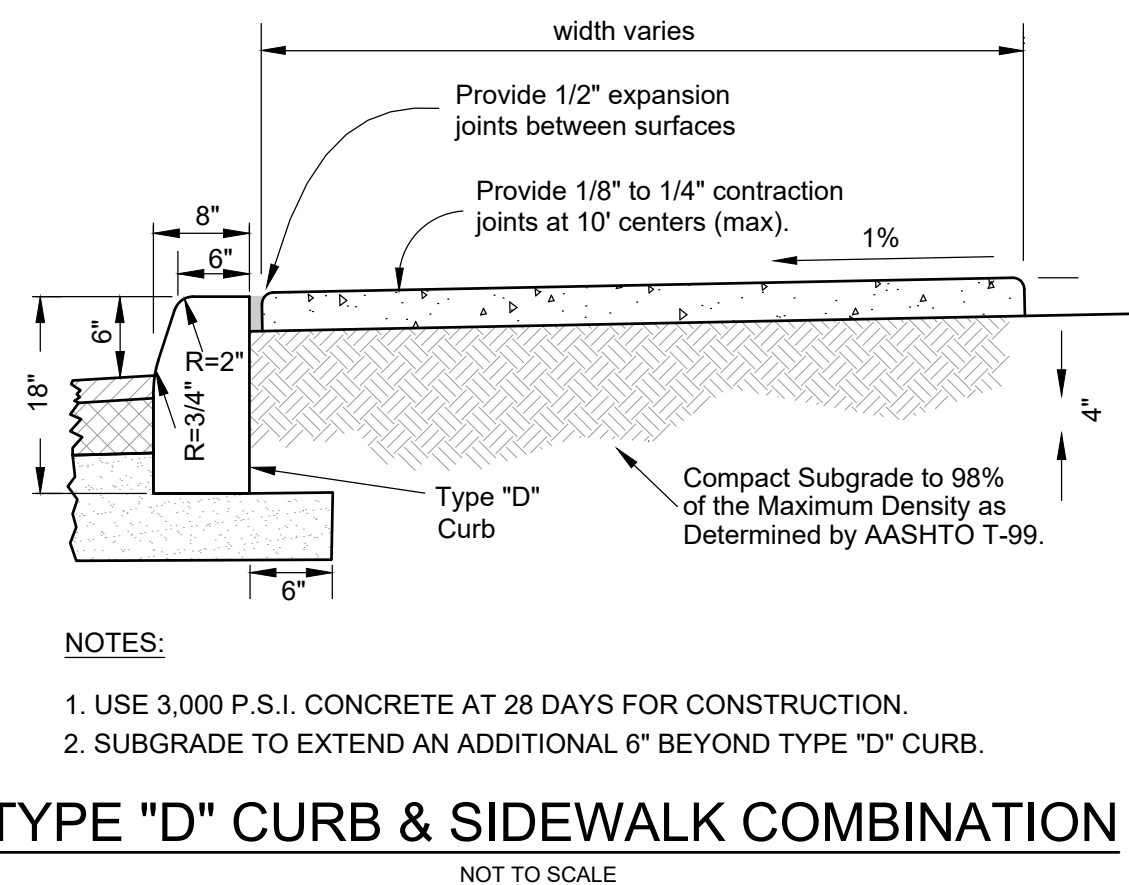
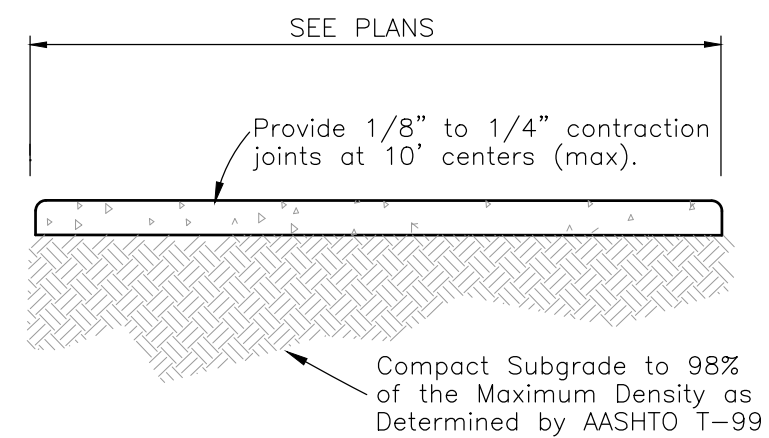
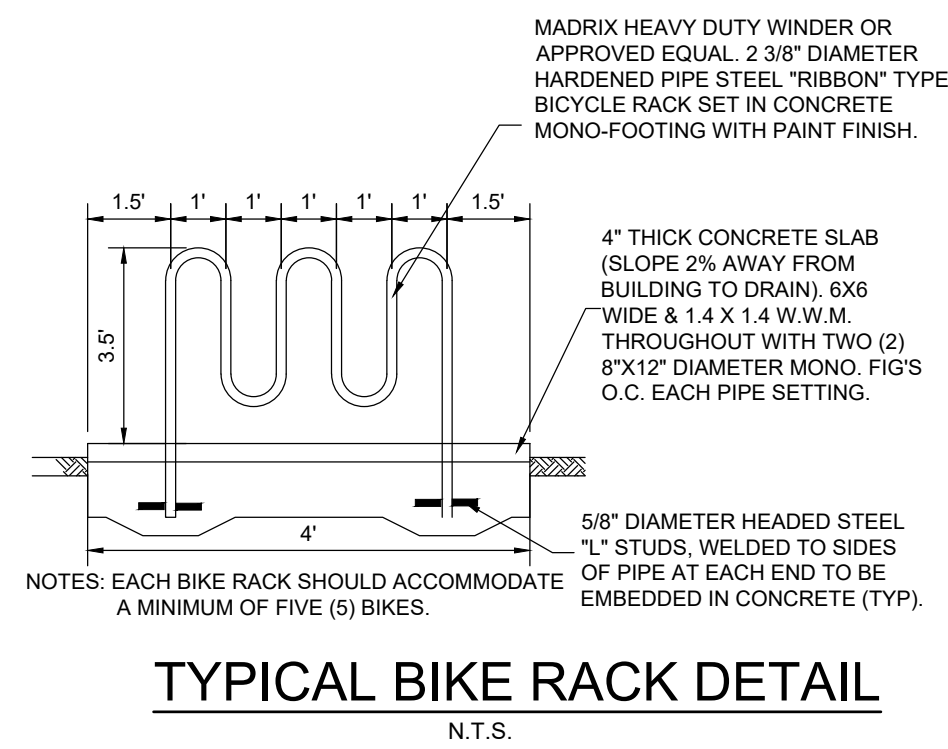




Luminaire Schedule								
Symbol	Qty	Label	MANUFACT	Description	Air Lum. Lumens	LLF	Lum. Watts	Total Watts
	14	SA	Gardco	ECF-S-64L-1A-NW-G2-4-HIS POLE MOUNT 25' AFG	20481	0.900	255.9	2882.6
	3	SB	Gardco	ECF-S-64L-1A-NW-G2-5W POLE MOUNT 25' AFG	27330	1.000	205.9	617.7
	3	SC	Gardco	ECF-S-48L-1A-NW-G2-3-HIS POLE MOUNT 25' AFG	15899	0.900	158.7	476.1
	1	SD	Gardco	ECF-S-32L-1A-NW-G2-3-HIS POLE MOUNT 25' AFG	10905	1.000	105.6	105.6



 ENGINEERS & SURVEYORS ENVIRONMENTAL & LAND PLANNERS INTERIOR DESIGNERS	
10250 VILLAGE PARKWAY SUITE 201 PORT ST. LUCIE, FL 34987 ☎ 772-462-2455 🌐 www.edc-inc.com	
F.B.P.E. CERTIFICATE OF AUTHORIZATION 9935 L.B. CERTIFICATE OF AUTHORIZATION 8098	
DESIGNED BY JRH	DRAWN BY JLV
FILE NAME 22-503 site plan r18.dwg	
DETAILS LAYOUT	
SCALE AS SHOWN	
DATE 04JUN2024	
REVISION COMMENTS	
DATE	
INNOVATION RESTAURANT HUB	
SITE PLAN DETAILS	
PORT ST LUCIE	
FLORIDA	
 ENGINEERS & SURVEYORS ENVIRONMENTAL & LAND PLANNERS INTERIOR DESIGNERS	
10250 SW VILLAGE PARKWAY - SUITE 201 PORT SAINT LUCIE, FL 34987 ☎ 772-462-2455	
22-503	
2 OF 2	